


● Water Bottle Refill Station

● Standard Water Fountain

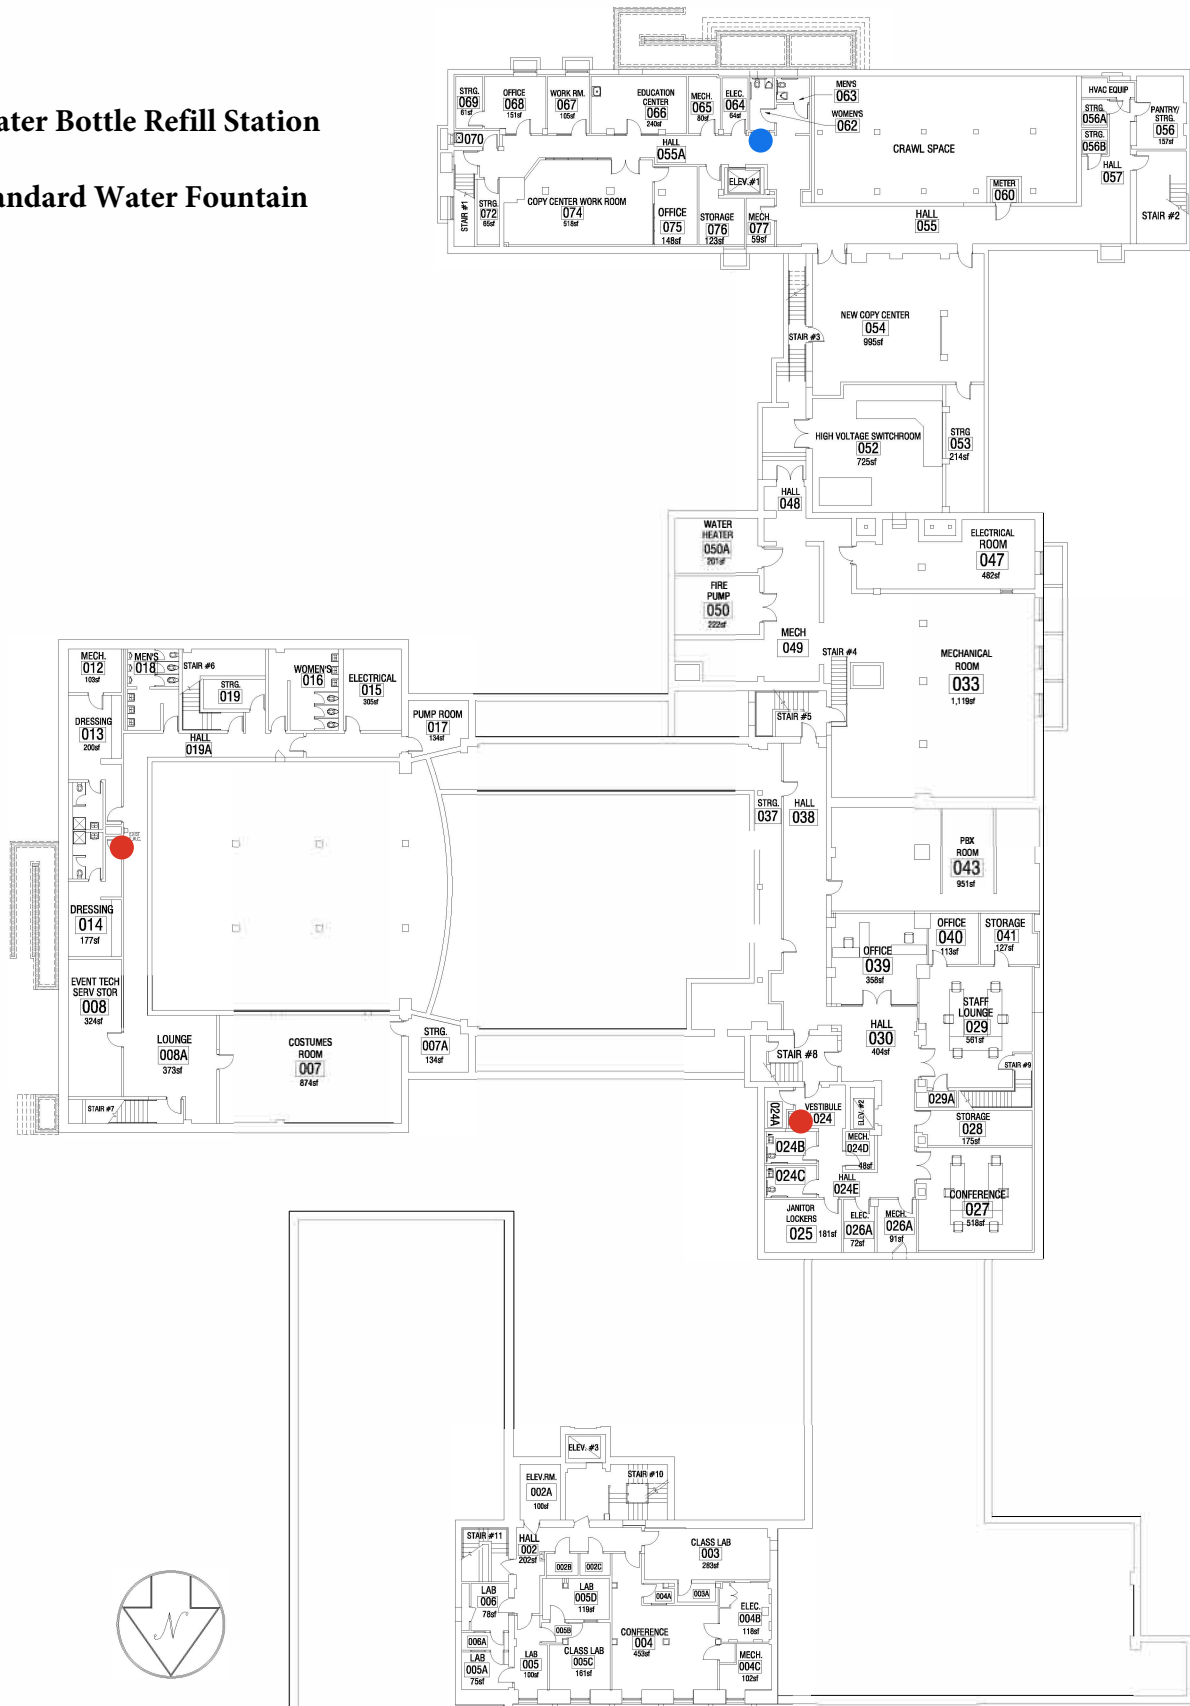

DWG. NO.:

A-0

BLDG CODE

HH

ISSUE DATE:

JUNE 29, 2023

SCALE:

NTS

DESIGN BY:

PLA

CHECKED BY:

MJG

**RECORD FLOOR PLAN  
HOLLOWAY HALL**

PROJECT

NAME:

**BASEMENT FLOOR PLAN**

**SALISBURY UNIVERSITY**

FACILITIES PLANNING & CAPITAL PROJECTS

ARCHITECTURAL AND ENGINEERING SERVICES


1101 CAMDEN AVENUE

SALISBURY, MARYLAND 21801

410 - 543 - 6215

● Water Bottle Refill Station

● Standard Water Fountain

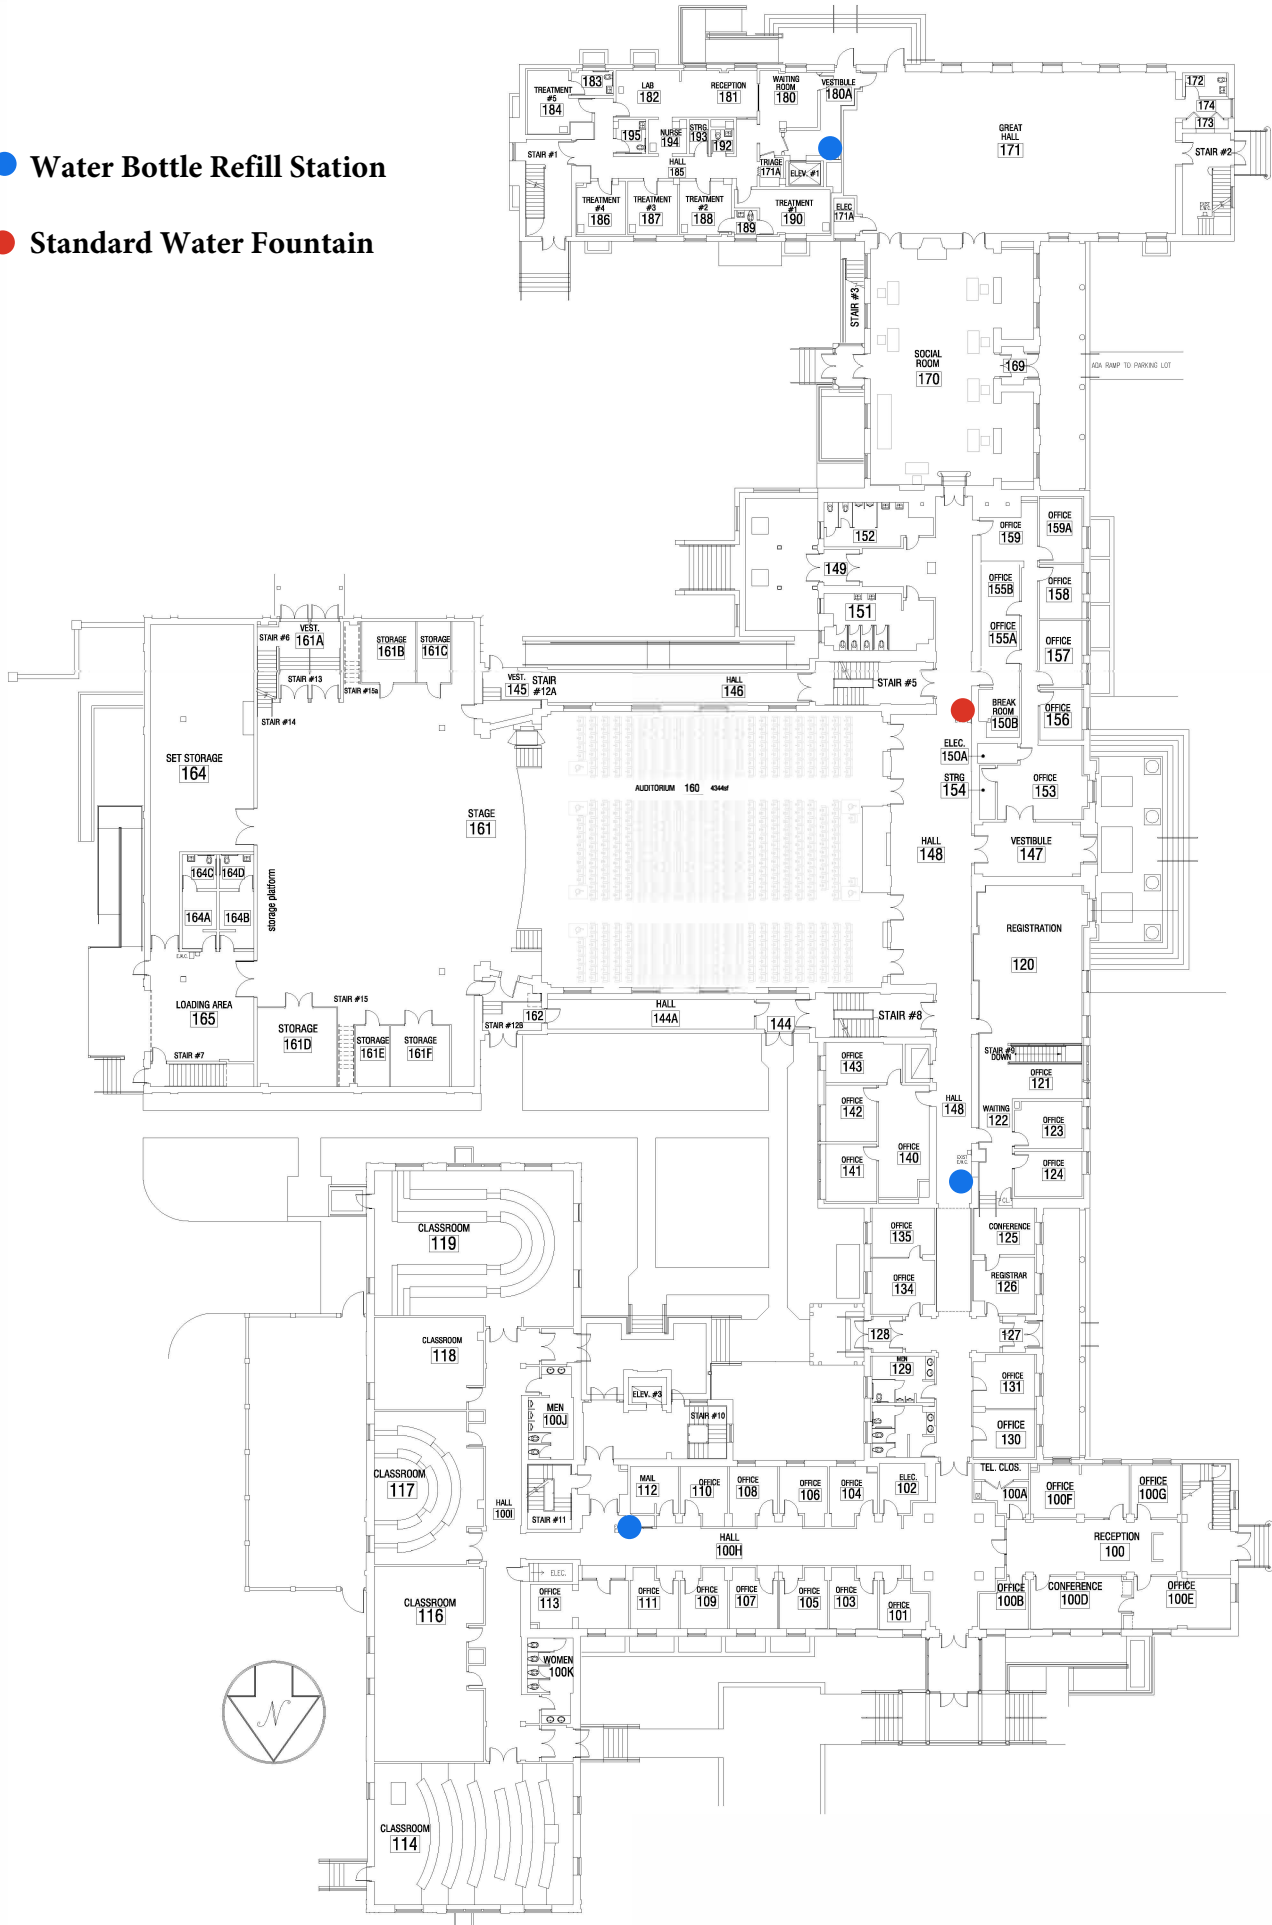

DWG. NO.:  
**A-1**  
BLDG CODE  
**HH**

ISSUE DATE:  
JUNE 29, 2023  
SCALE:  
**NTS**  
CHECKED BY:  
MJG




**RECORD FLOOR PLAN  
HOLLOWAY HALL**

PROJECT  
NAME:  
**FIRST FLOOR PLAN**

**SALISBURY UNIVERSITY**  
FACILITIES PLANNING & CAPITAL PROJECTS  
ARCHITECTURAL AND ENGINEERING SERVICES  
1101 CAMDEN AVENUE  
SALISBURY, MARYLAND 21801  
410 - 543 - 6215

● Water Bottle Refill Station



● Standard Water Fountain

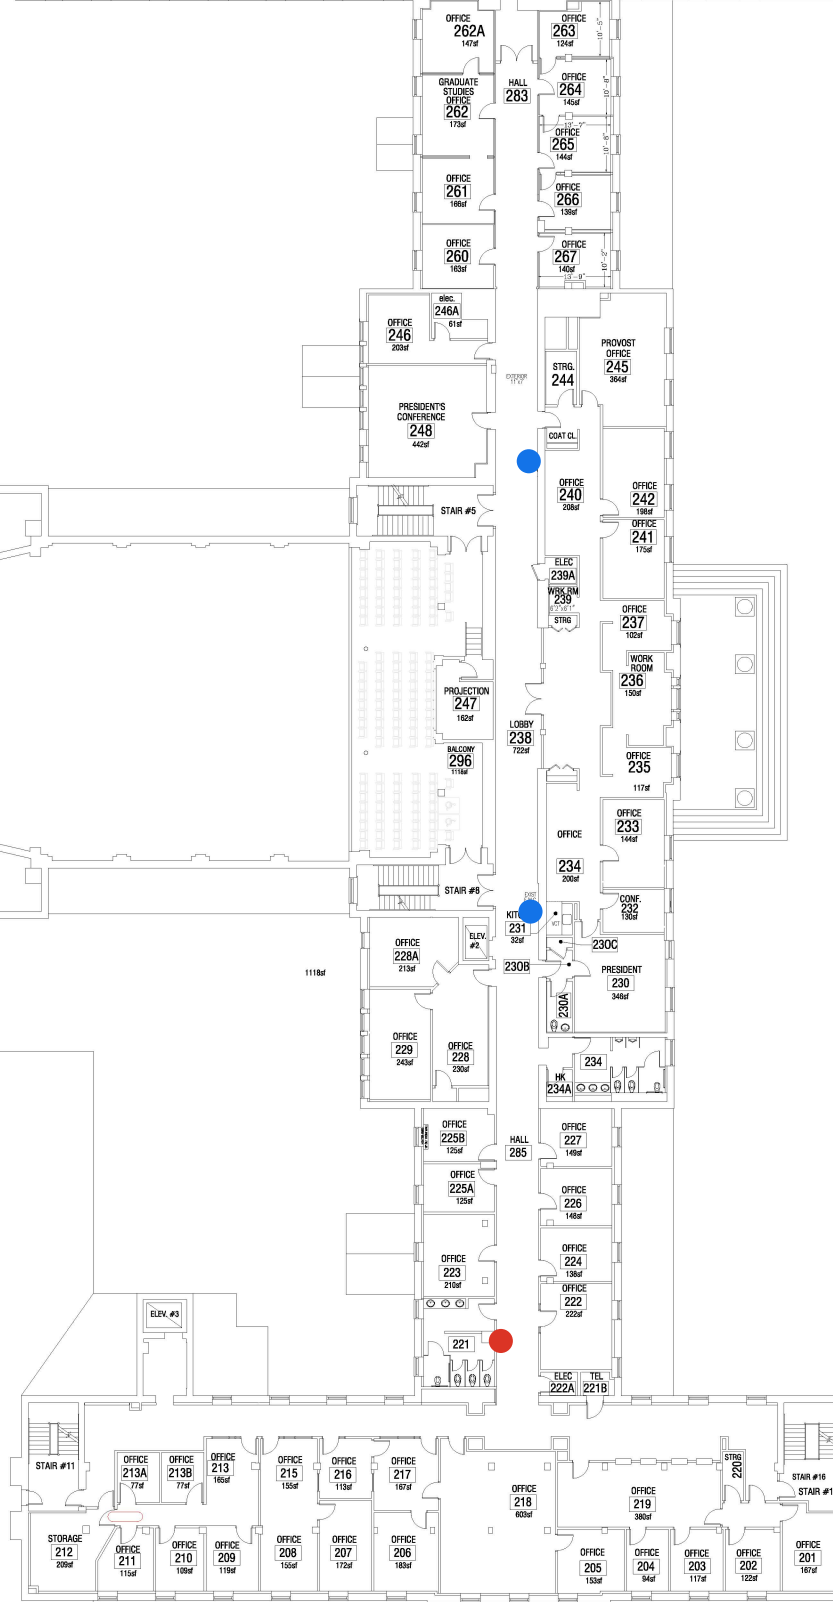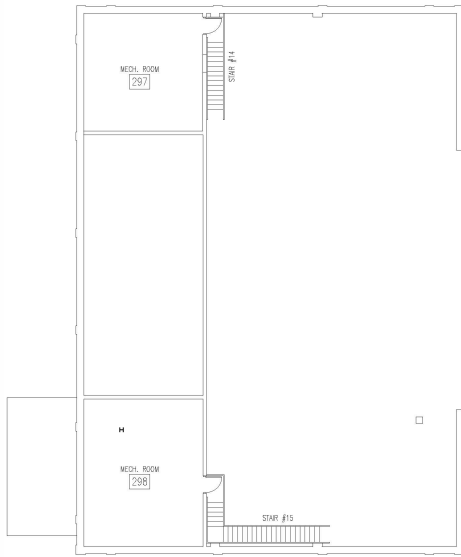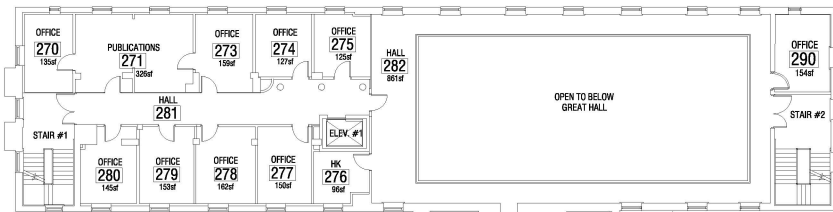

DWG. NO.: <b>A-2</b> BLDG CODE <b>HH</b>	ISSUE DATE: <b>JUNE 29, 2023</b>	PROJECT NAME: <b>RECORD FLOOR PLAN HOLLOWAY HALL SECOND FLOOR PLAN</b>	<b>SALISBURY UNIVERSITY</b> FACILITIES PLANNING & CAPITAL PROJECTS ARCHITECTURAL AND ENGINEERING SERVICES 1101 CAMDEN AVENUE SALISBURY, MARYLAND 21801 410 - 543 - 6215
	SCALE: <b>NTS</b>		
	DESIGN BY: <b>PLL</b>		
	CHECKED BY: <b>MJG</b>		

● Water Bottle Refill Station

● Standard Water Fountain

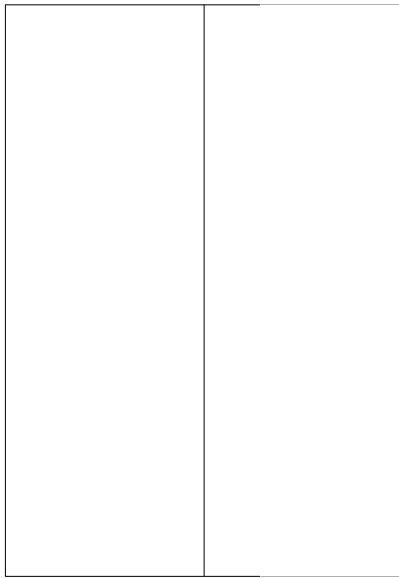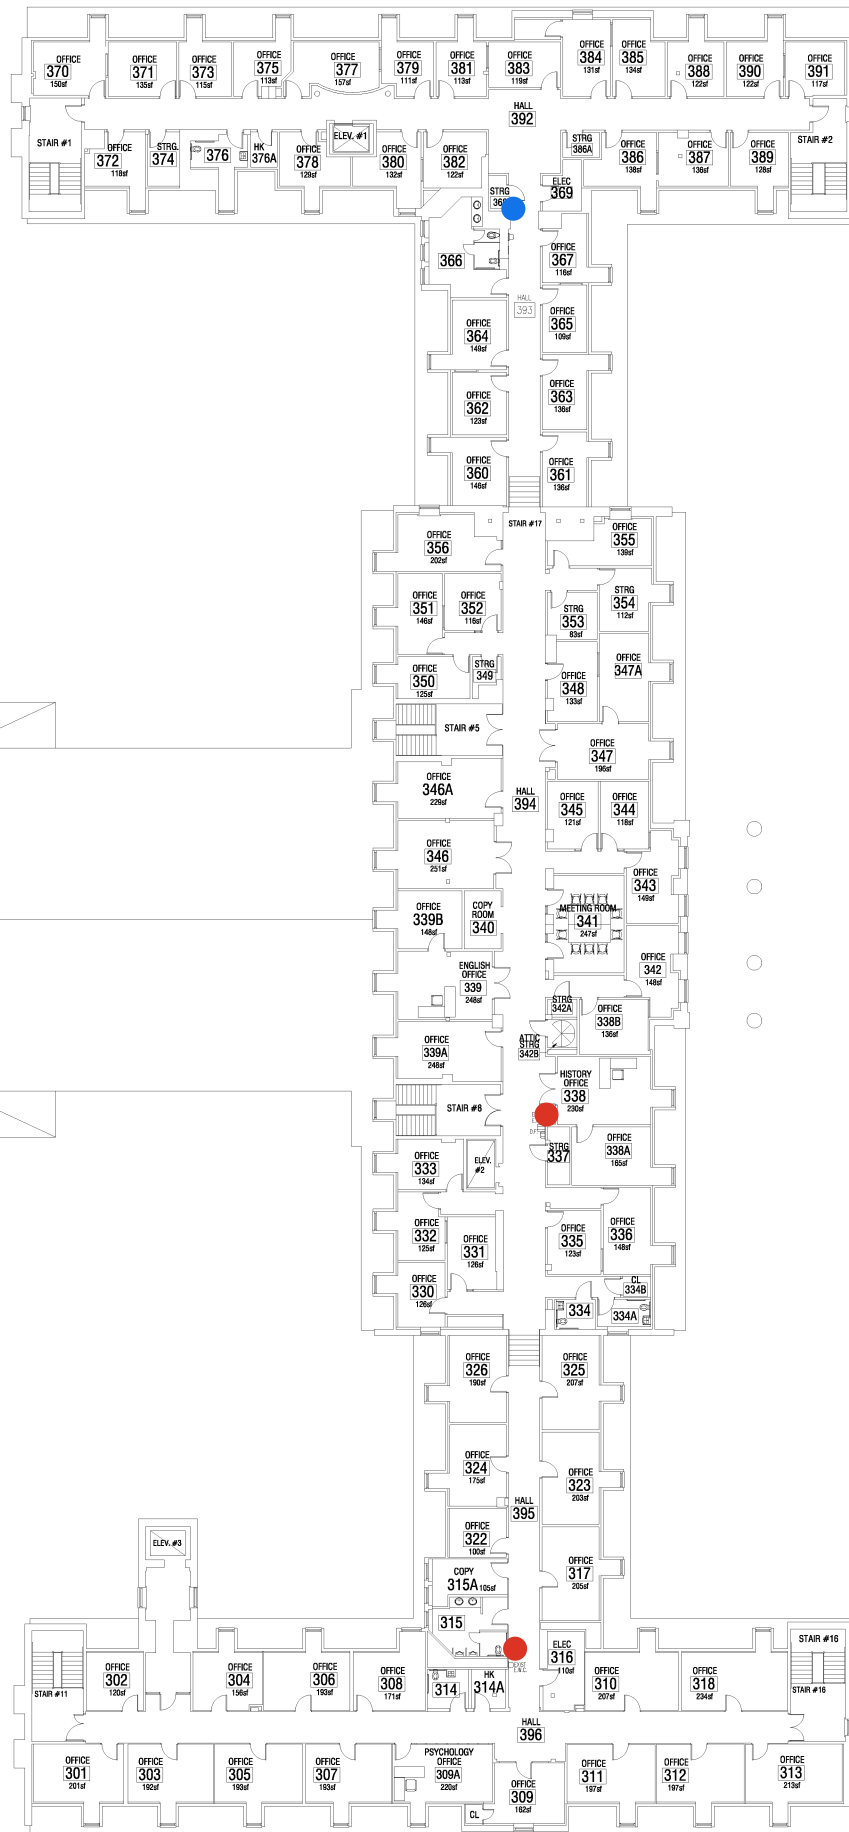

DWG. NO.:

**A-3**

BLDG CODE

**HH**

ISSUE DATE:  
JUNE 29, 2023

SCALE: **NTS**

DESIGN BY:  
PLL

CHECKED BY:  
MJG

**RECORD FLOOR PLAN  
HOLLOWAY HALL**

PROJECT  
NAME:

**THIRD FLOOR PLAN**

**SALISBURY UNIVERSITY**  
FACILITIES PLANNING & CAPITAL PROJECTS  
ARCHITECTURAL AND ENGINEERING SERVICES  
1101 CAMDEN AVENUE  
SALISBURY, MARYLAND 21801  
410 - 543 - 6215