


● Water Bottle Refill Station

● Standard Water Fountain

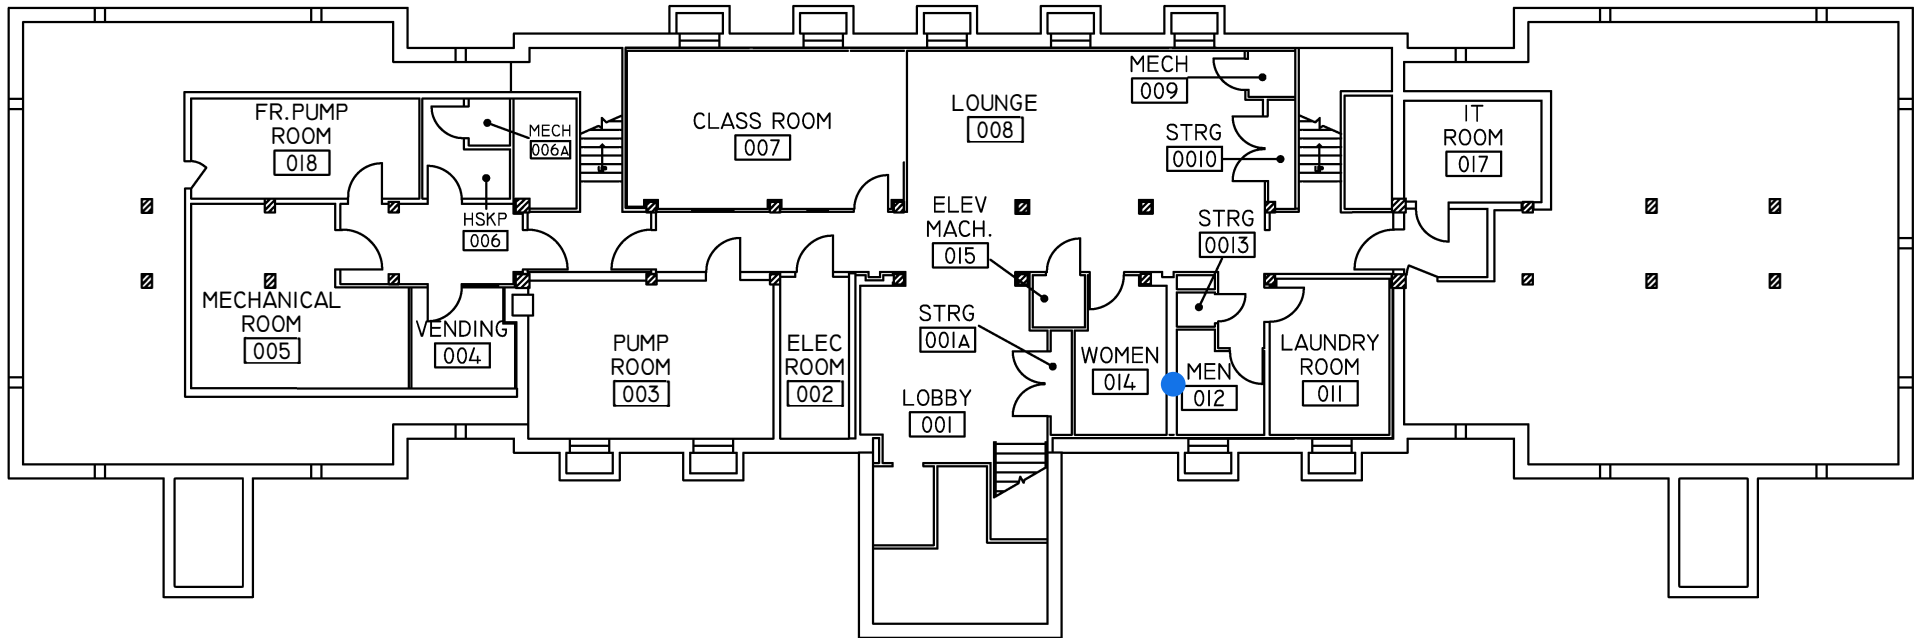


DWG. NO.:	ISSUE DATE:
A-0	JUNE 22, 2018
BLDG. CODE	SCALE:
MK	NTS
	DESIGN BY:
	PLA
	CHECKED BY:
	JCD

**RECORD FLOOR PLAN
MANOKIN HALL**

PROJECT NAME:
BASEMENT FLOOR PLAN

SALISBURY UNIVERSITY
FACILITIES PLANNING & CAPITAL PROJECTS
ARCHITECTURAL AND ENGINEERING SERVICES
1101 CAMDEN AVENUE
SALISBURY, MARYLAND 21801
410 - 543 - 6215

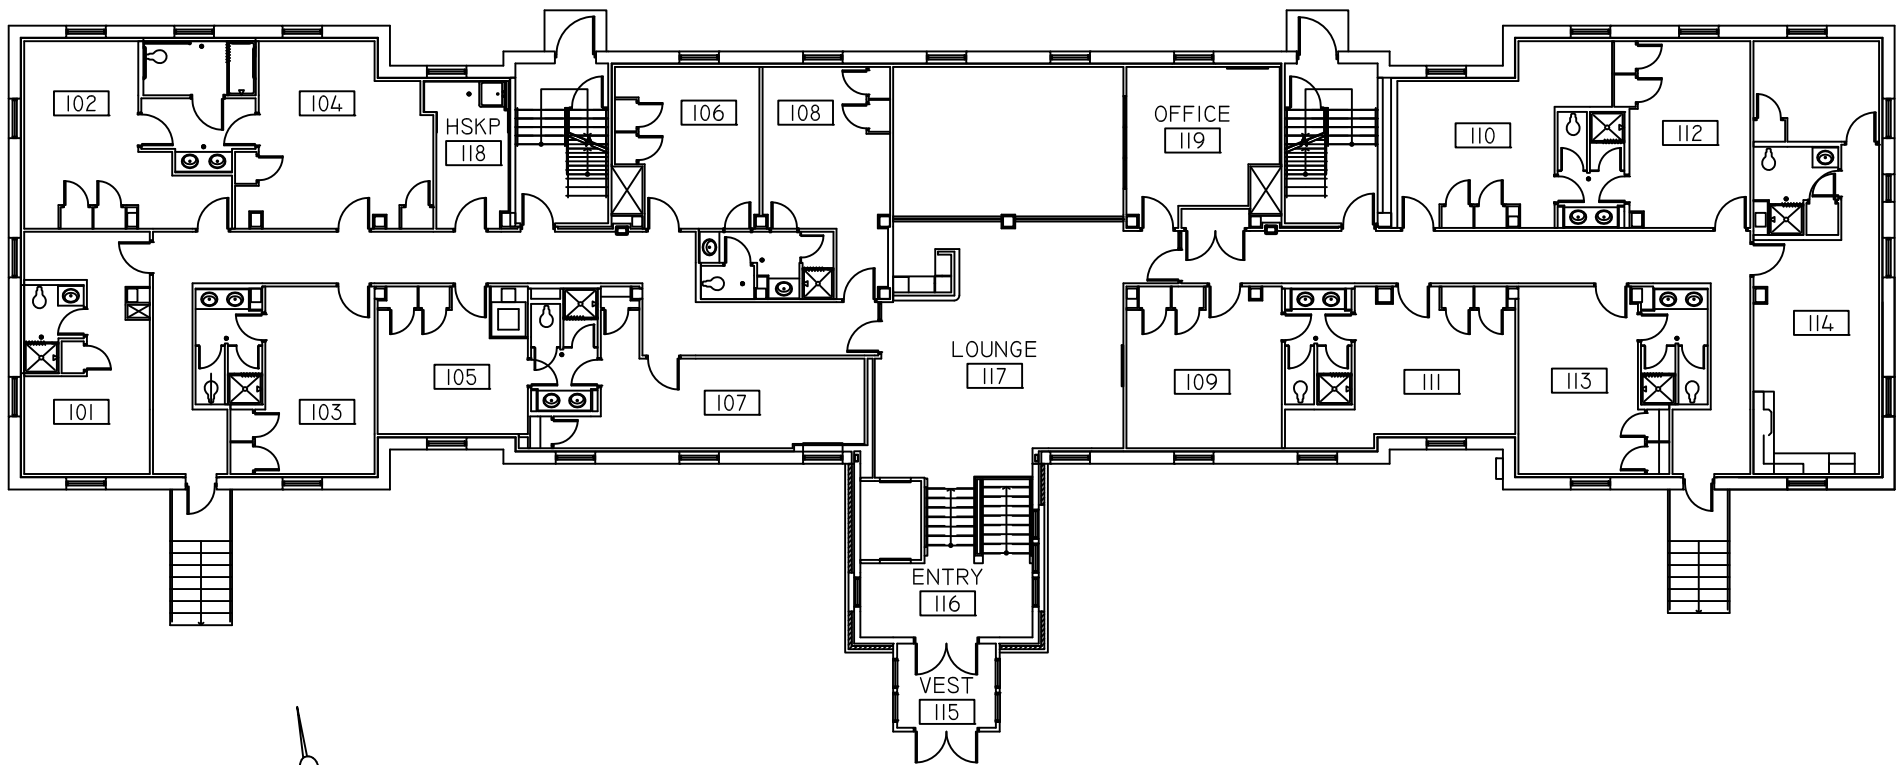

DWG. NO.:

A-1

BLDG. CODE

MK

ISSUE DATE:
JUNE 22, 2018

SCALE:
NTS

DESIGN BY:
PLA

CHECKED BY:
JCD

RECORD FLOOR PLAN
MANOKIN HALL

PROJECT
NAME:


FIRST FLOOR PLAN

SALISBURY UNIVERSITY

FACILITIES PLANNING & CAPITAL PROJECTS
ARCHITECTURAL AND ENGINEERING SERVICES

1101 CAMDEN AVENUE
SALISBURY, MARYLAND 21801

410 - 543 - 6215

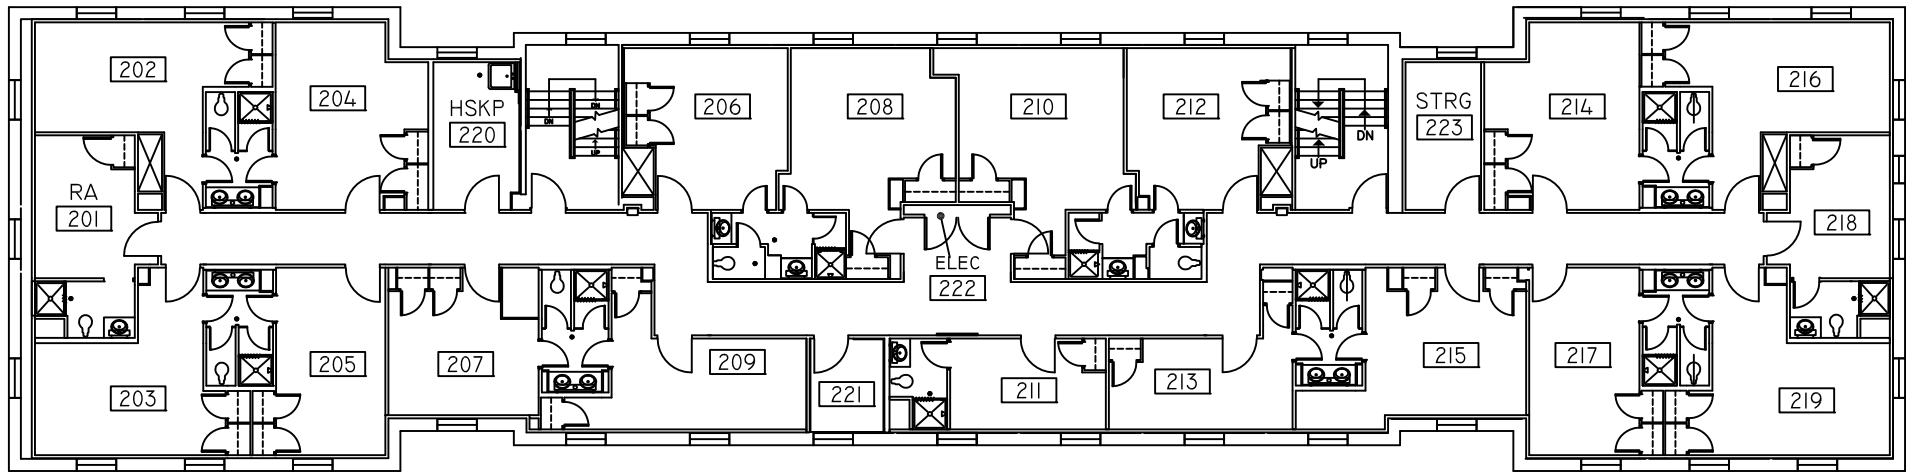

DWG. NO.:

A-2

BLDG. CODE

MK

ISSUE DATE:
JUNE 22, 2018

SCALE:
NTS

DESIGN BY:
PLA

CHECKED BY:
JCD

RECORD FLOOR PLAN
MANOKIN HALL

PROJECT
NAME:


SECOND FLOOR PLAN

SALISBURY UNIVERSITY

FACILITIES PLANNING & CAPITAL PROJECTS
ARCHITECTURAL AND ENGINEERING SERVICES

1101 CAMDEN AVENUE
SALISBURY, MARYLAND 21801

410 - 543 - 6215

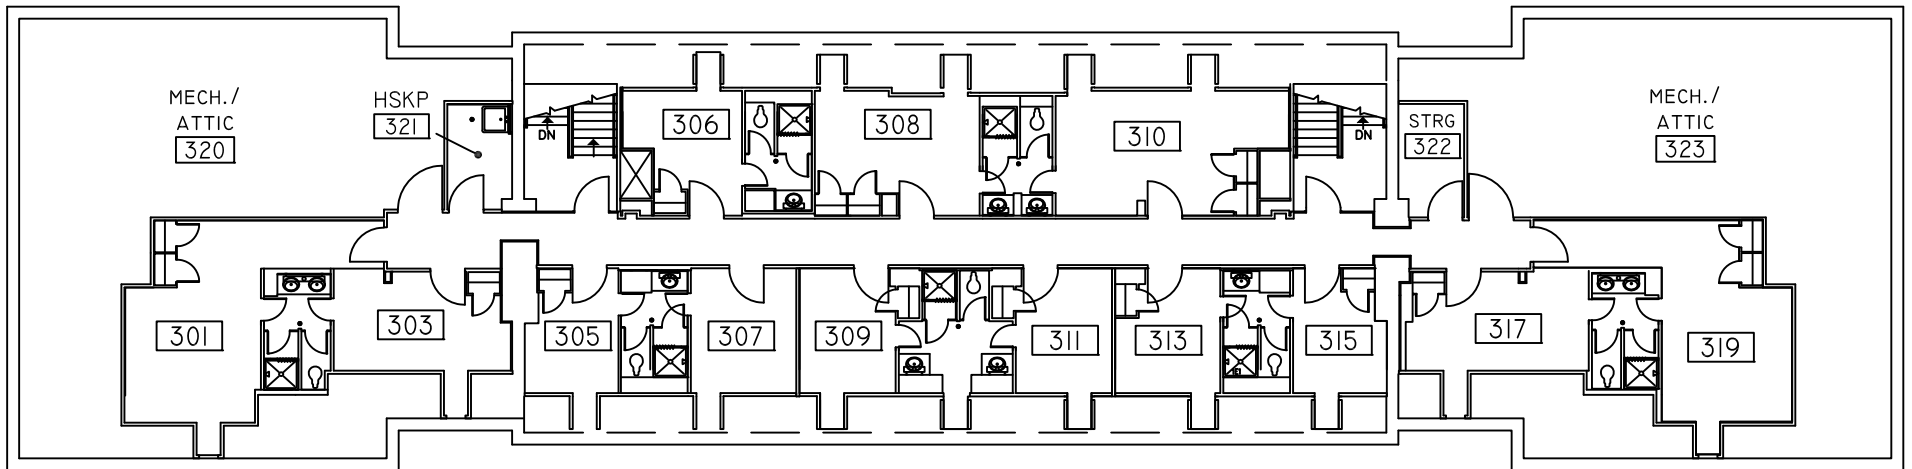

DWG. NO.:
A-3
 BLDG. CODE
MK

ISSUE DATE:
 JUNE 22, 2018
 SCALE:
NTS
 DESIGN BY:
PLA
 CHECKED BY:
JCD

**RECORD FLOOR PLAN
 MANOKIN HALL**

PROJECT
 NAME:
THIRD FLOOR PLAN

SALISBURY UNIVERSITY
 FACILITIES PLANNING & CAPITAL PROJECTS
 ARCHITECTURAL AND ENGINEERING SERVICES
 1101 CAMDEN AVENUE
 SALISBURY, MARYLAND 21801
 410 - 543 - 6215